




PLAN VIEW

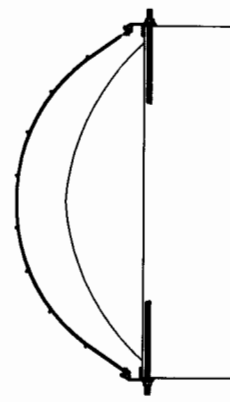

END VIEW

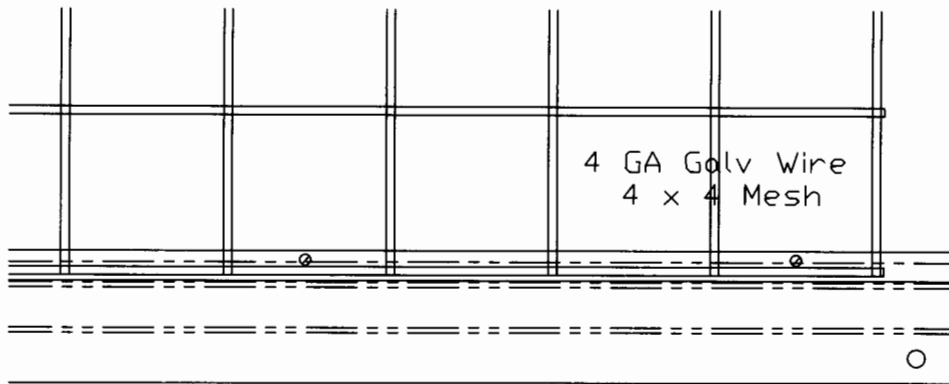

FRONT ELEVATION 4X

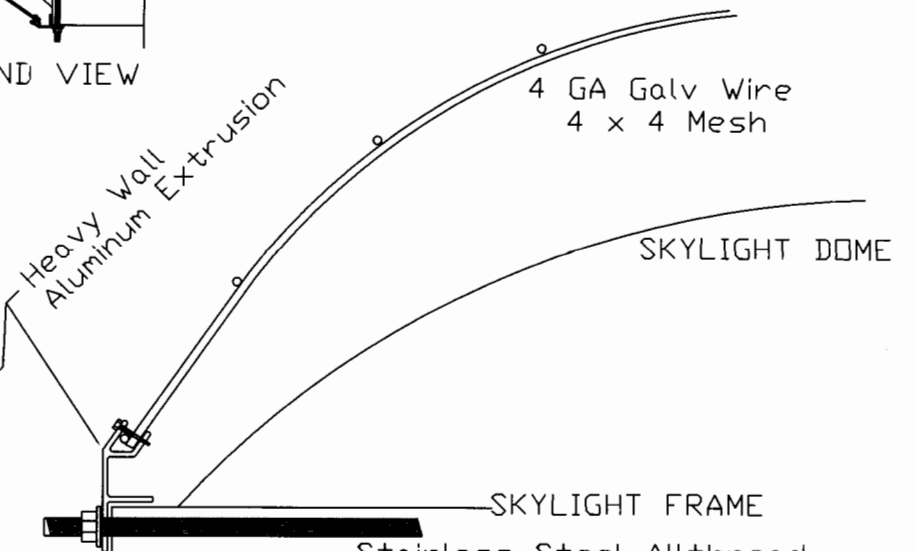

END SECTION 4X



WINCHESTER FABRICATORS INC.
 705 N. JAMES RD. PHONE: (614) 235-4577
 COLUMBUS, OH 43219 FAX: (614) 235-3070

| |
|---------------------------------|
| TOLERANCES (EXCEPT AS NOTED) |
| DECIMAL +/- |
| FRACTIONAL +/- |
| ANGULAR +/- |

| REVISIONS | | | |
|-----------|------|----|-------------|
| NO. | DATE | BY | DESCRIPTION |
| | | | |
| | | | |
| | | | |
| | | | |

| | | | |
|-----------------|-------------------|------------------------------|--------------------------------------------------|
| DRAWN BY: JS | SCALE: NTS | MATERIAL: AS NOTED | CUSTOMER: |
| CHECKED: | DATE: 10-21-03 | DRAWING NO: DOME SKYLIGHT | DRAWING TITLE: TYPICAL DETAILS DOME SKYLIGHTS |